

 

Luminaire Schedule							
Symbol	Qty	Label	Arrangement	Lumens/Lamp	LLF	Total Watts	Description
○	6	NTA-T4	SINGLE	19200	1.000	780	NTA-A-NM-T4-19L-40K-UL-BZ
○	1	NTA-T3	SINGLE	19200	1.000	130	NTA-A-NM-T3-19L-40K-UL-BZ

Calculation Summary					
Label	Avg	Max	Min	Avg/Min	Max/Min
CalcPts_1	1.32	17.6	0.0	N.A.	N.A.
Parking Area South	2.71	11.4	0.2	13.55	57.00

Additional Required Equipment:
 (7) NTA-DA-BZ-U Adjustable arm
 (7) E-ACWM4DB L shaped wall mounting bracket

Customer to verify Color, Mounting, Fixture Location and Voltage prior to ordering.

Extra proposed fixture

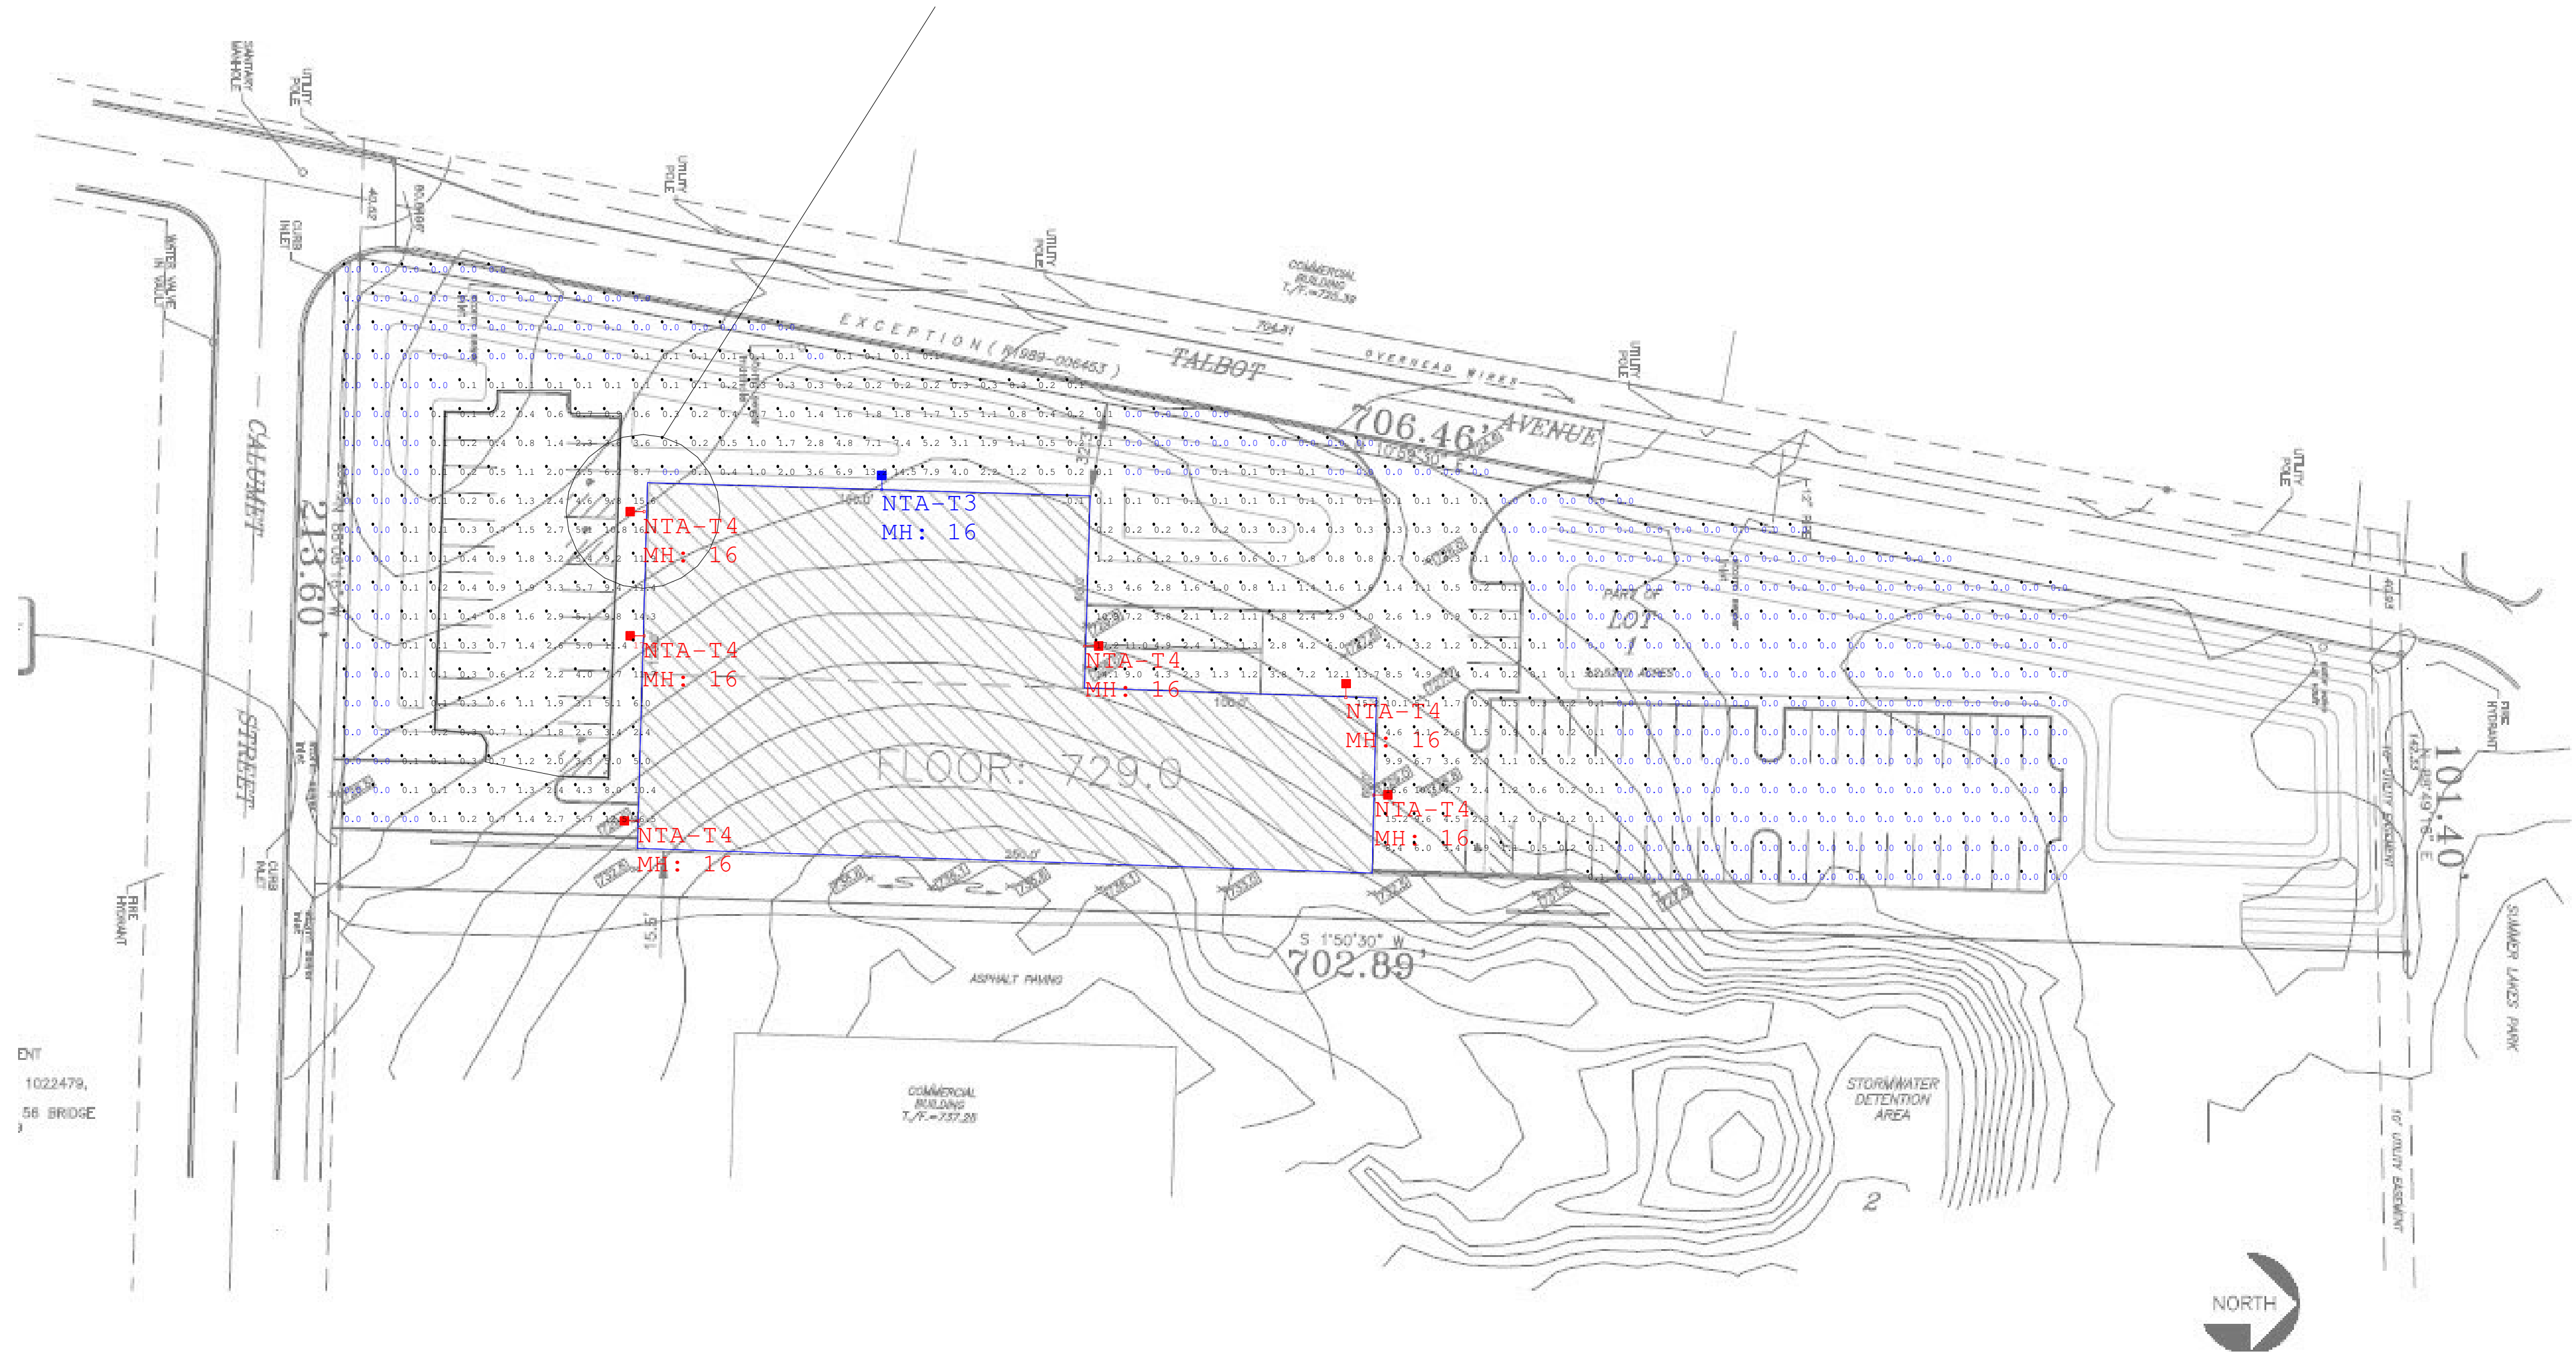

1501 96th Street
 Sturtevant, Wisconsin 53177
 PH: (888) 243-9445
 FX: (262) 504-5409
 www.e-conolight.com

Customer responsible to verify ordering information/catalogue number prior to placing order.

Date: 12/8/2020 Scale: 1"=40' Layout by: Nicholas Passeri

Project Name: Elite, Warrenville, IL Salesforce: SR-33924

Filename: V:\Common\Eng\Working\Nrp\2020 Virtual Drawer\Outdoor\12 DEC\1207 - SR33924

Footcandles calculated at grade using initial lumen values

Illumination results shown on this lighting design are based on project parameters provided to E-conolight used in conjunction with luminaire test procedures conducted under laboratory conditions. Actual project conditions differing from these design parameters may affect field results. The customer is responsible for verifying dimensional accuracy along with compliance with any applicable electrical, lighting, or energy code.